


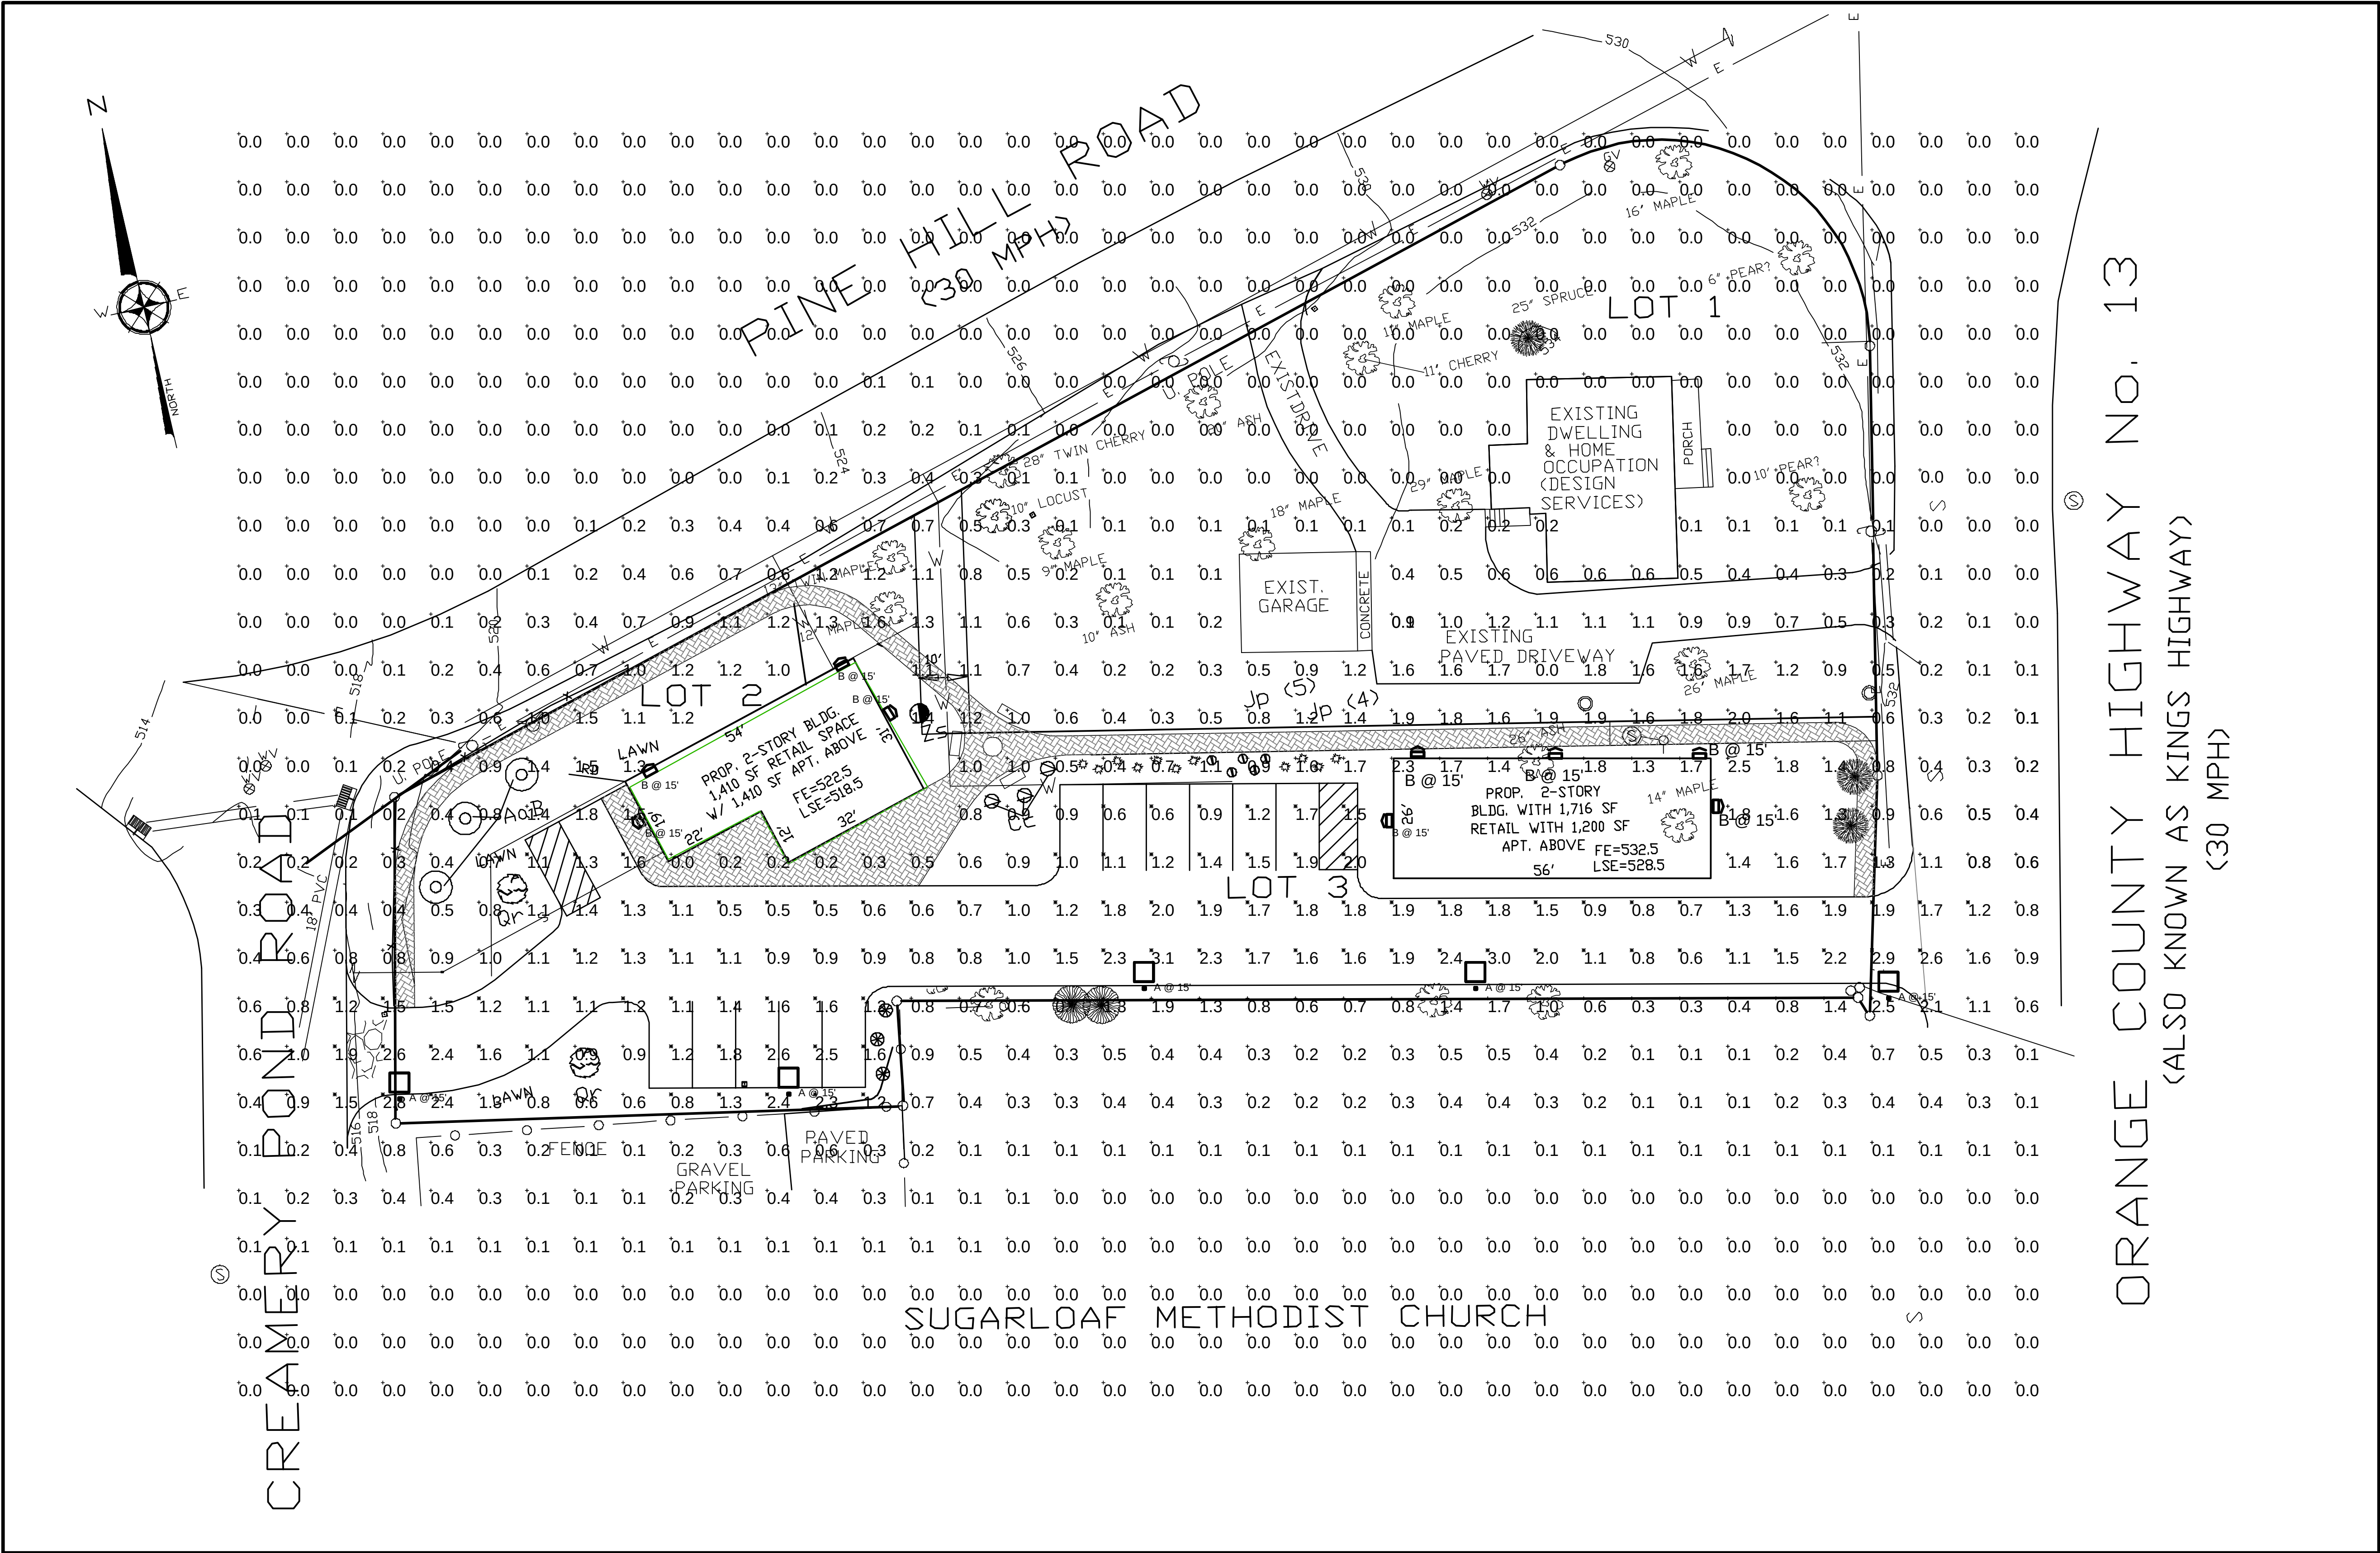

| Schedule |       |          |                            |                                     |                                                                                                                        |           |              |                                         |                 |
|----------|-------|----------|----------------------------|-------------------------------------|------------------------------------------------------------------------------------------------------------------------|-----------|--------------|-----------------------------------------|-----------------|
| Symbol   | Label | Quantity | Manufacturer               | Catalog Number                      | Description                                                                                                            | Lamp      | Number Lamps | Filename                                | Lumens Per Lamp |
|          | A     | 5        | American Electric Lighting | ATB0 10BLEDE15 XXXXX R4 4K5K        | ATB0 SERIES LED 1500MA TYPE 4 4000K/5000 K CCT                                                                         | LED Array | 1            | ATB0_10BLE DE15_XXXXX_R4_4K_5K.ies      | 5653            |
|          | B     | 9        | Holophane                  | HLWPC2 P10 50K XX T1FTM XXXXX 80CRI | Wallpack Full Cutoff LED, LED Performance Package P10, 5000 series CCT, Voltage, Forward Throw Medium with 80 CRI LEDs | LED       | 1            | HLWPC2_P10 50K_XX_TF TM_XXXXX_80CRI.ies | 2809            |

Lighting as shown, or approved equal.

| Statistics        |        |        |        |        |         |         |
|-------------------|--------|--------|--------|--------|---------|---------|
| Description       | Symbol | Avg    | Max    | Min    | Max/Min | Avg/Min |
| parking lot       |        | 1.5 fc | 3.1 fc | 0.5 fc | 6.2:1   | 3.0:1   |
| SITE CALCULATIONS | +      | 0.4 fc | 3.1 fc | 0.0 fc | N/A     | N/A     |

Note  
1. Readings shown are based on a total LLF as shown at grade.  
Data references the extrapolated performance projections in a 25c ambient based on 10,000 hrs of LED testing (per IESNA LM-80-08 and projected per IESNA TM-21-11)  
2. Please refer to the "luminaire locations" table for mounting heights.  
3- Product information can be obtained at www.Holophane.com or through your local agency.

|                                                                                        |          |                                                  |
|----------------------------------------------------------------------------------------|----------|--------------------------------------------------|
| 7                                                                                      | 12/19/17 | FOR PB REVIEW                                    |
| ISSUE                                                                                  | DATE     | DESCRIPTION                                      |
| SUBDIVISION FOR<br>DORIAN DEHAAN & JOHN CONDATORE, JR.                                 |          |                                                  |
| SECTION 14, BLOCK 6, LOT 1<br>TOWN OF CHESTER<br>ORANGE COUNTY, NEW YORK               |          |                                                  |
| LIGHTING PLAN                                                                          |          |                                                  |
| LEHMAN & GETZ, P.C.<br>CONSULTING ENGINEERS<br>17 RIVER STREET WARWICK, NEW YORK 10990 |          |                                                  |
| DAVID A. GETZ, P.E.<br>N.Y.S. LIC. No. 61265                                           |          |                                                  |
| DRAWN BY: K.H.E.<br>CHECKED BY: D.G.<br>JOB No. 1169                                   |          | DATE: 4/19/06<br>SCALE: 1" = 20'<br>SHEET 5 OF 5 |