
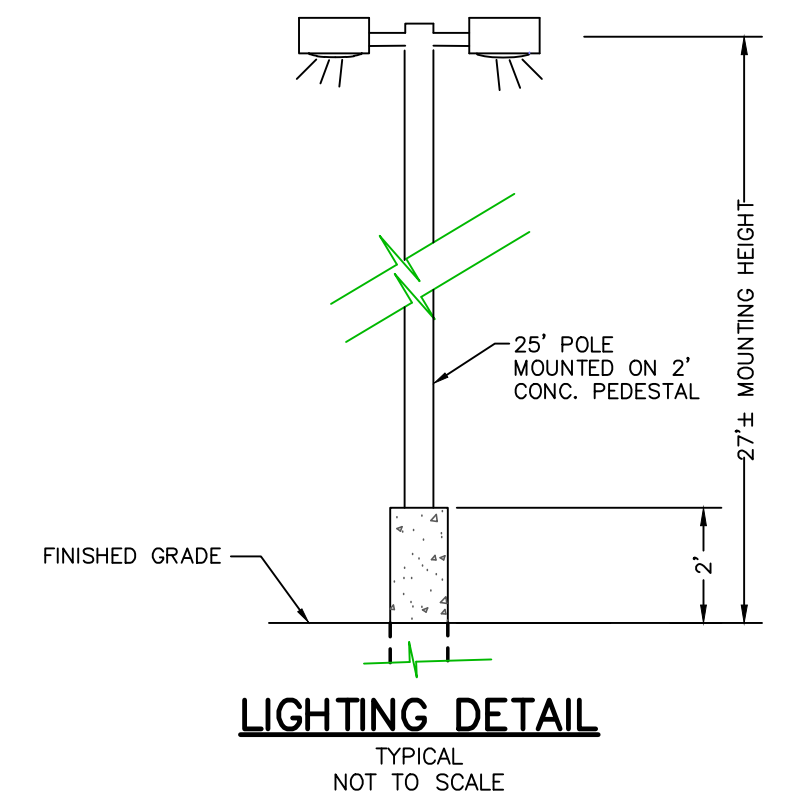
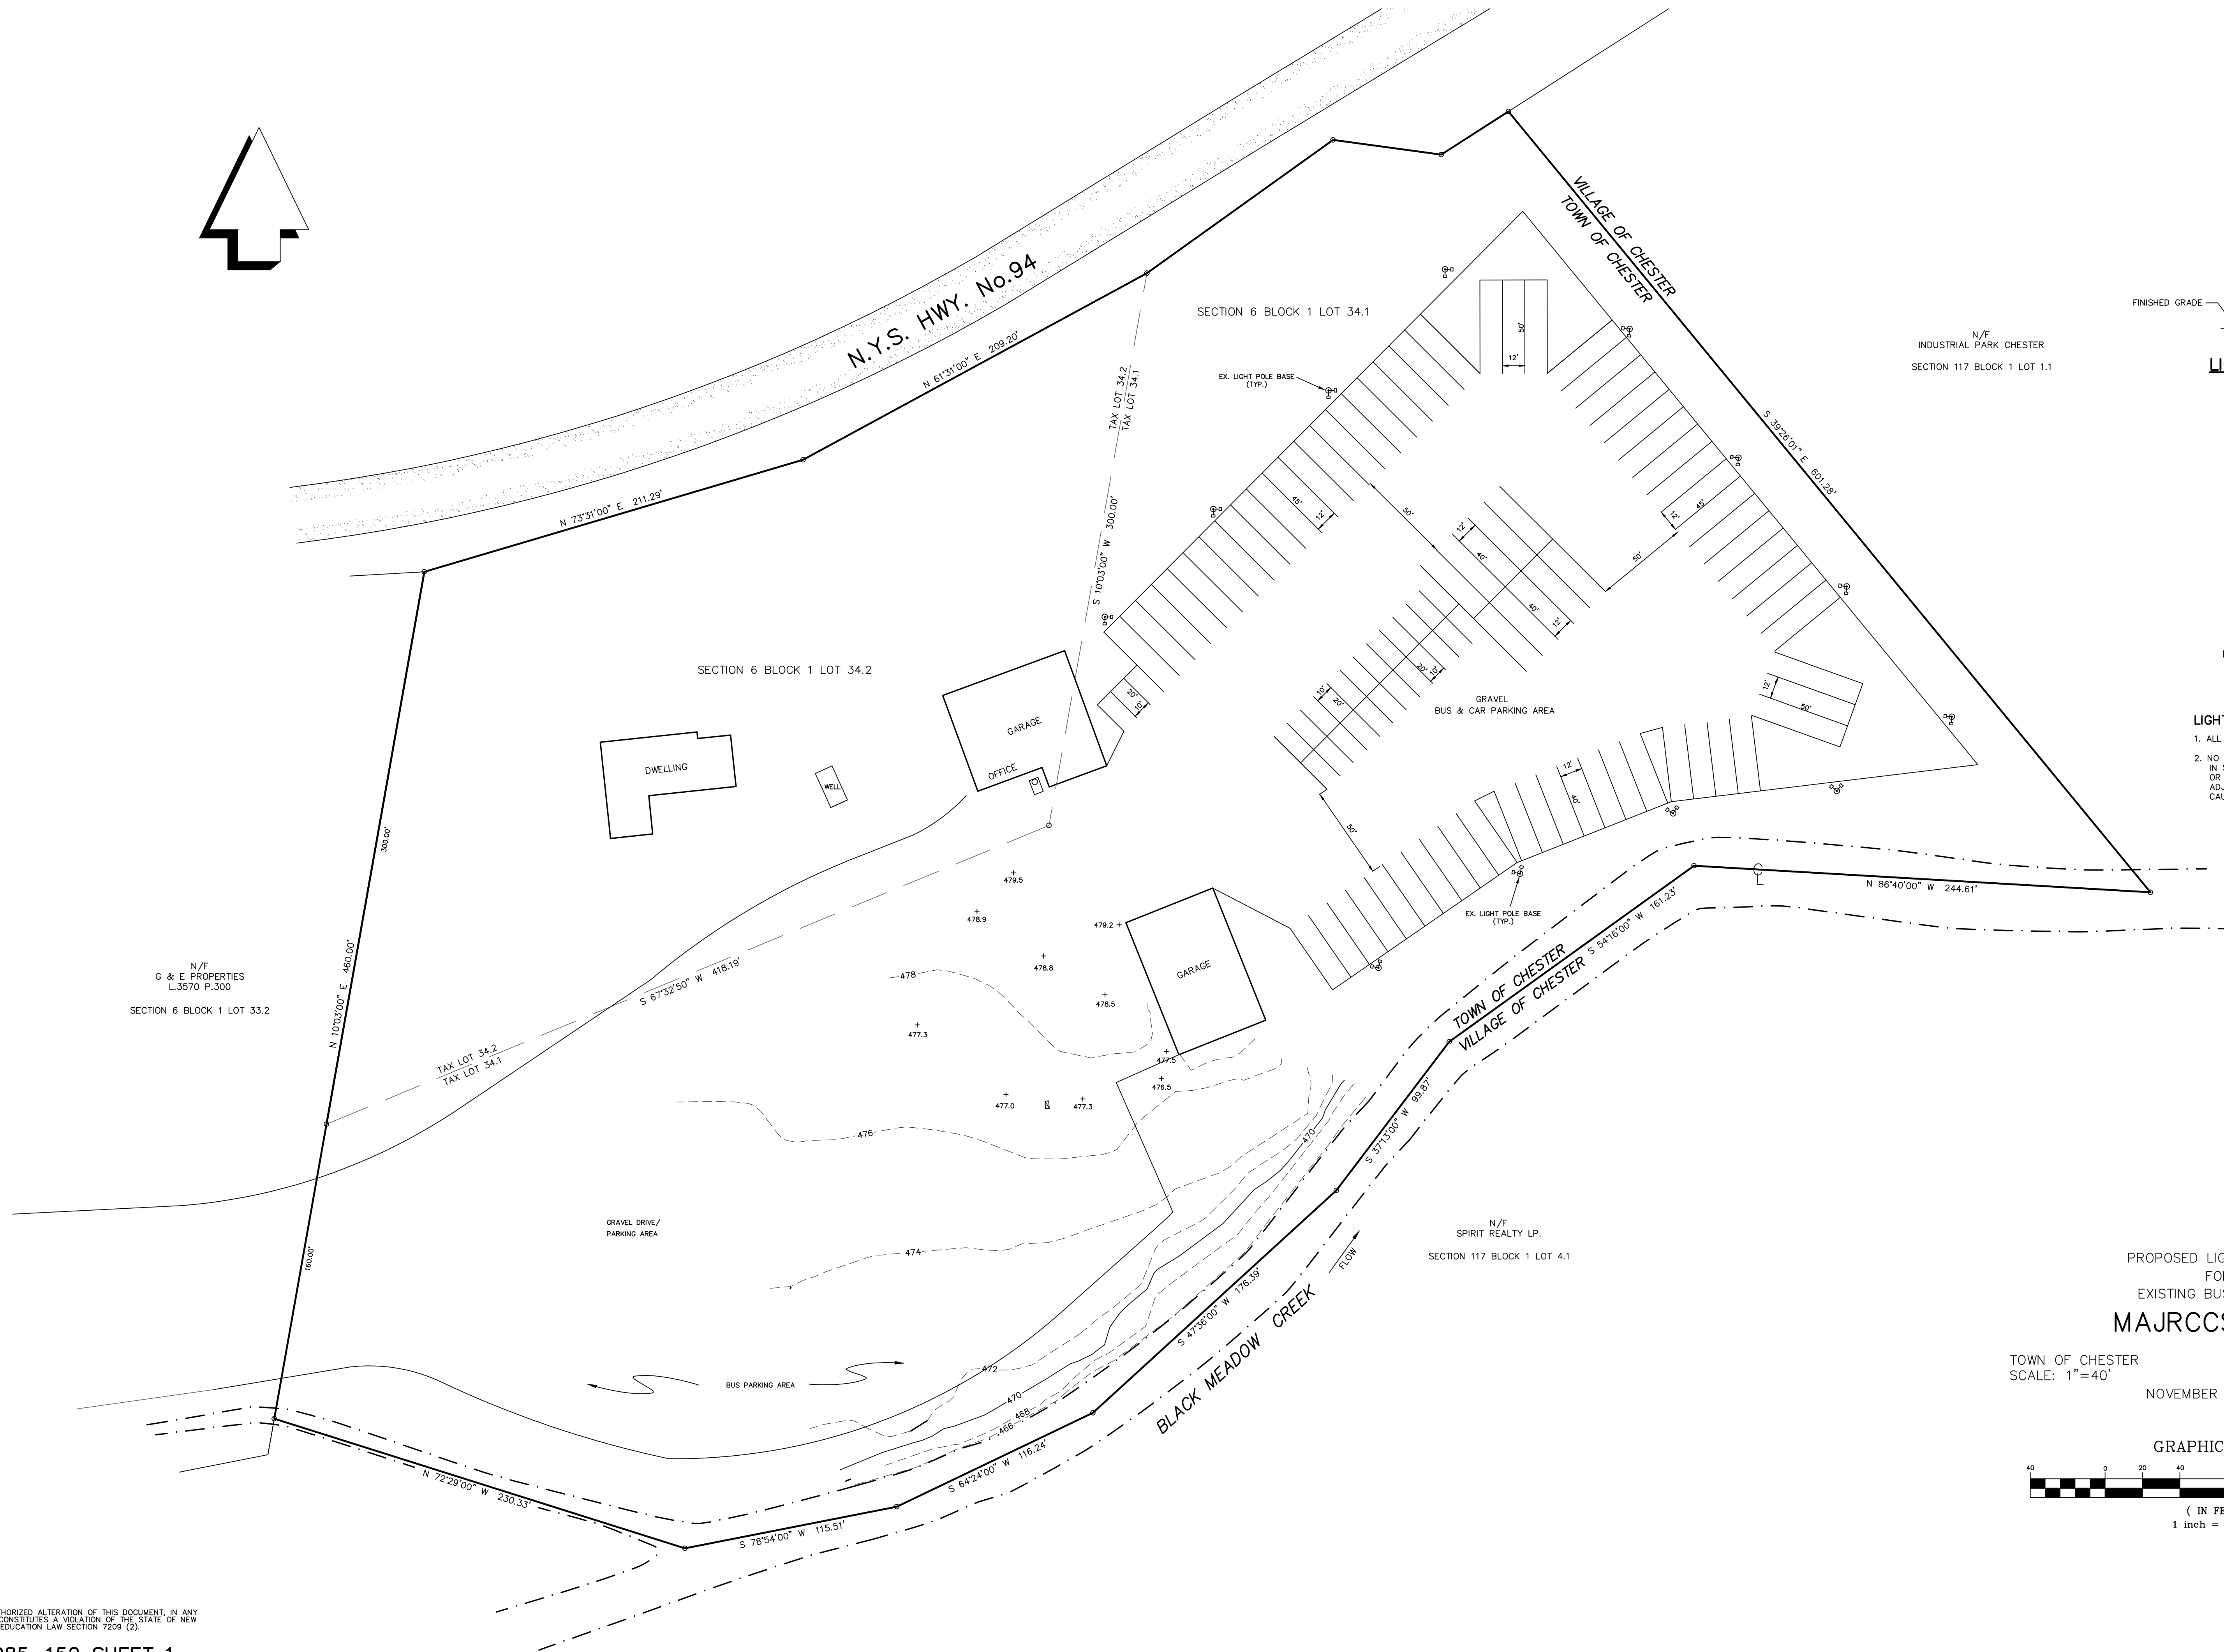


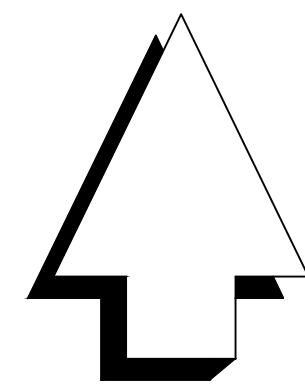

FLOODLIGHT LED LIGHT
DESCRIPTION: RAB PIPXL100SFN BULLHORN
RAB LIGHTING
(888) 722-1000

LIGHTING NOTES:

1. ALL LIGHTING FIXTURES SHALL BE FACED DOWNWARD.
2. NO FLOODLIGHT, SPOTLIGHT OR OTHER LIGHT SHALL BE ERECTED IN SUCH A MANNER THAT ITS BEAM SHALL BE DIRECTED, IN WHOLE OR IN PART, TOWARD A STREET, ROAD OR HIGHWAY OR TOWARD ADJOINING PROPERTY, OR IN ANY WAY OR MANNER THAT WILL CAUSE A TRAFFIC HAZARD DUE TO ITS GLARE.

PROPOSED LIGHTING PLAN
FOR
EXISTING BUS PARKING
MAJRCCS LLC.

TOWN OF CHESTER ORANGE COUNTY, N.Y.
SCALE: 1"=40' TOTAL AREA=9.46± ACRES
NOVEMBER 24, 2020

